


ELECTRICAL LAY-OUT

SCALE

1 : 100 M.

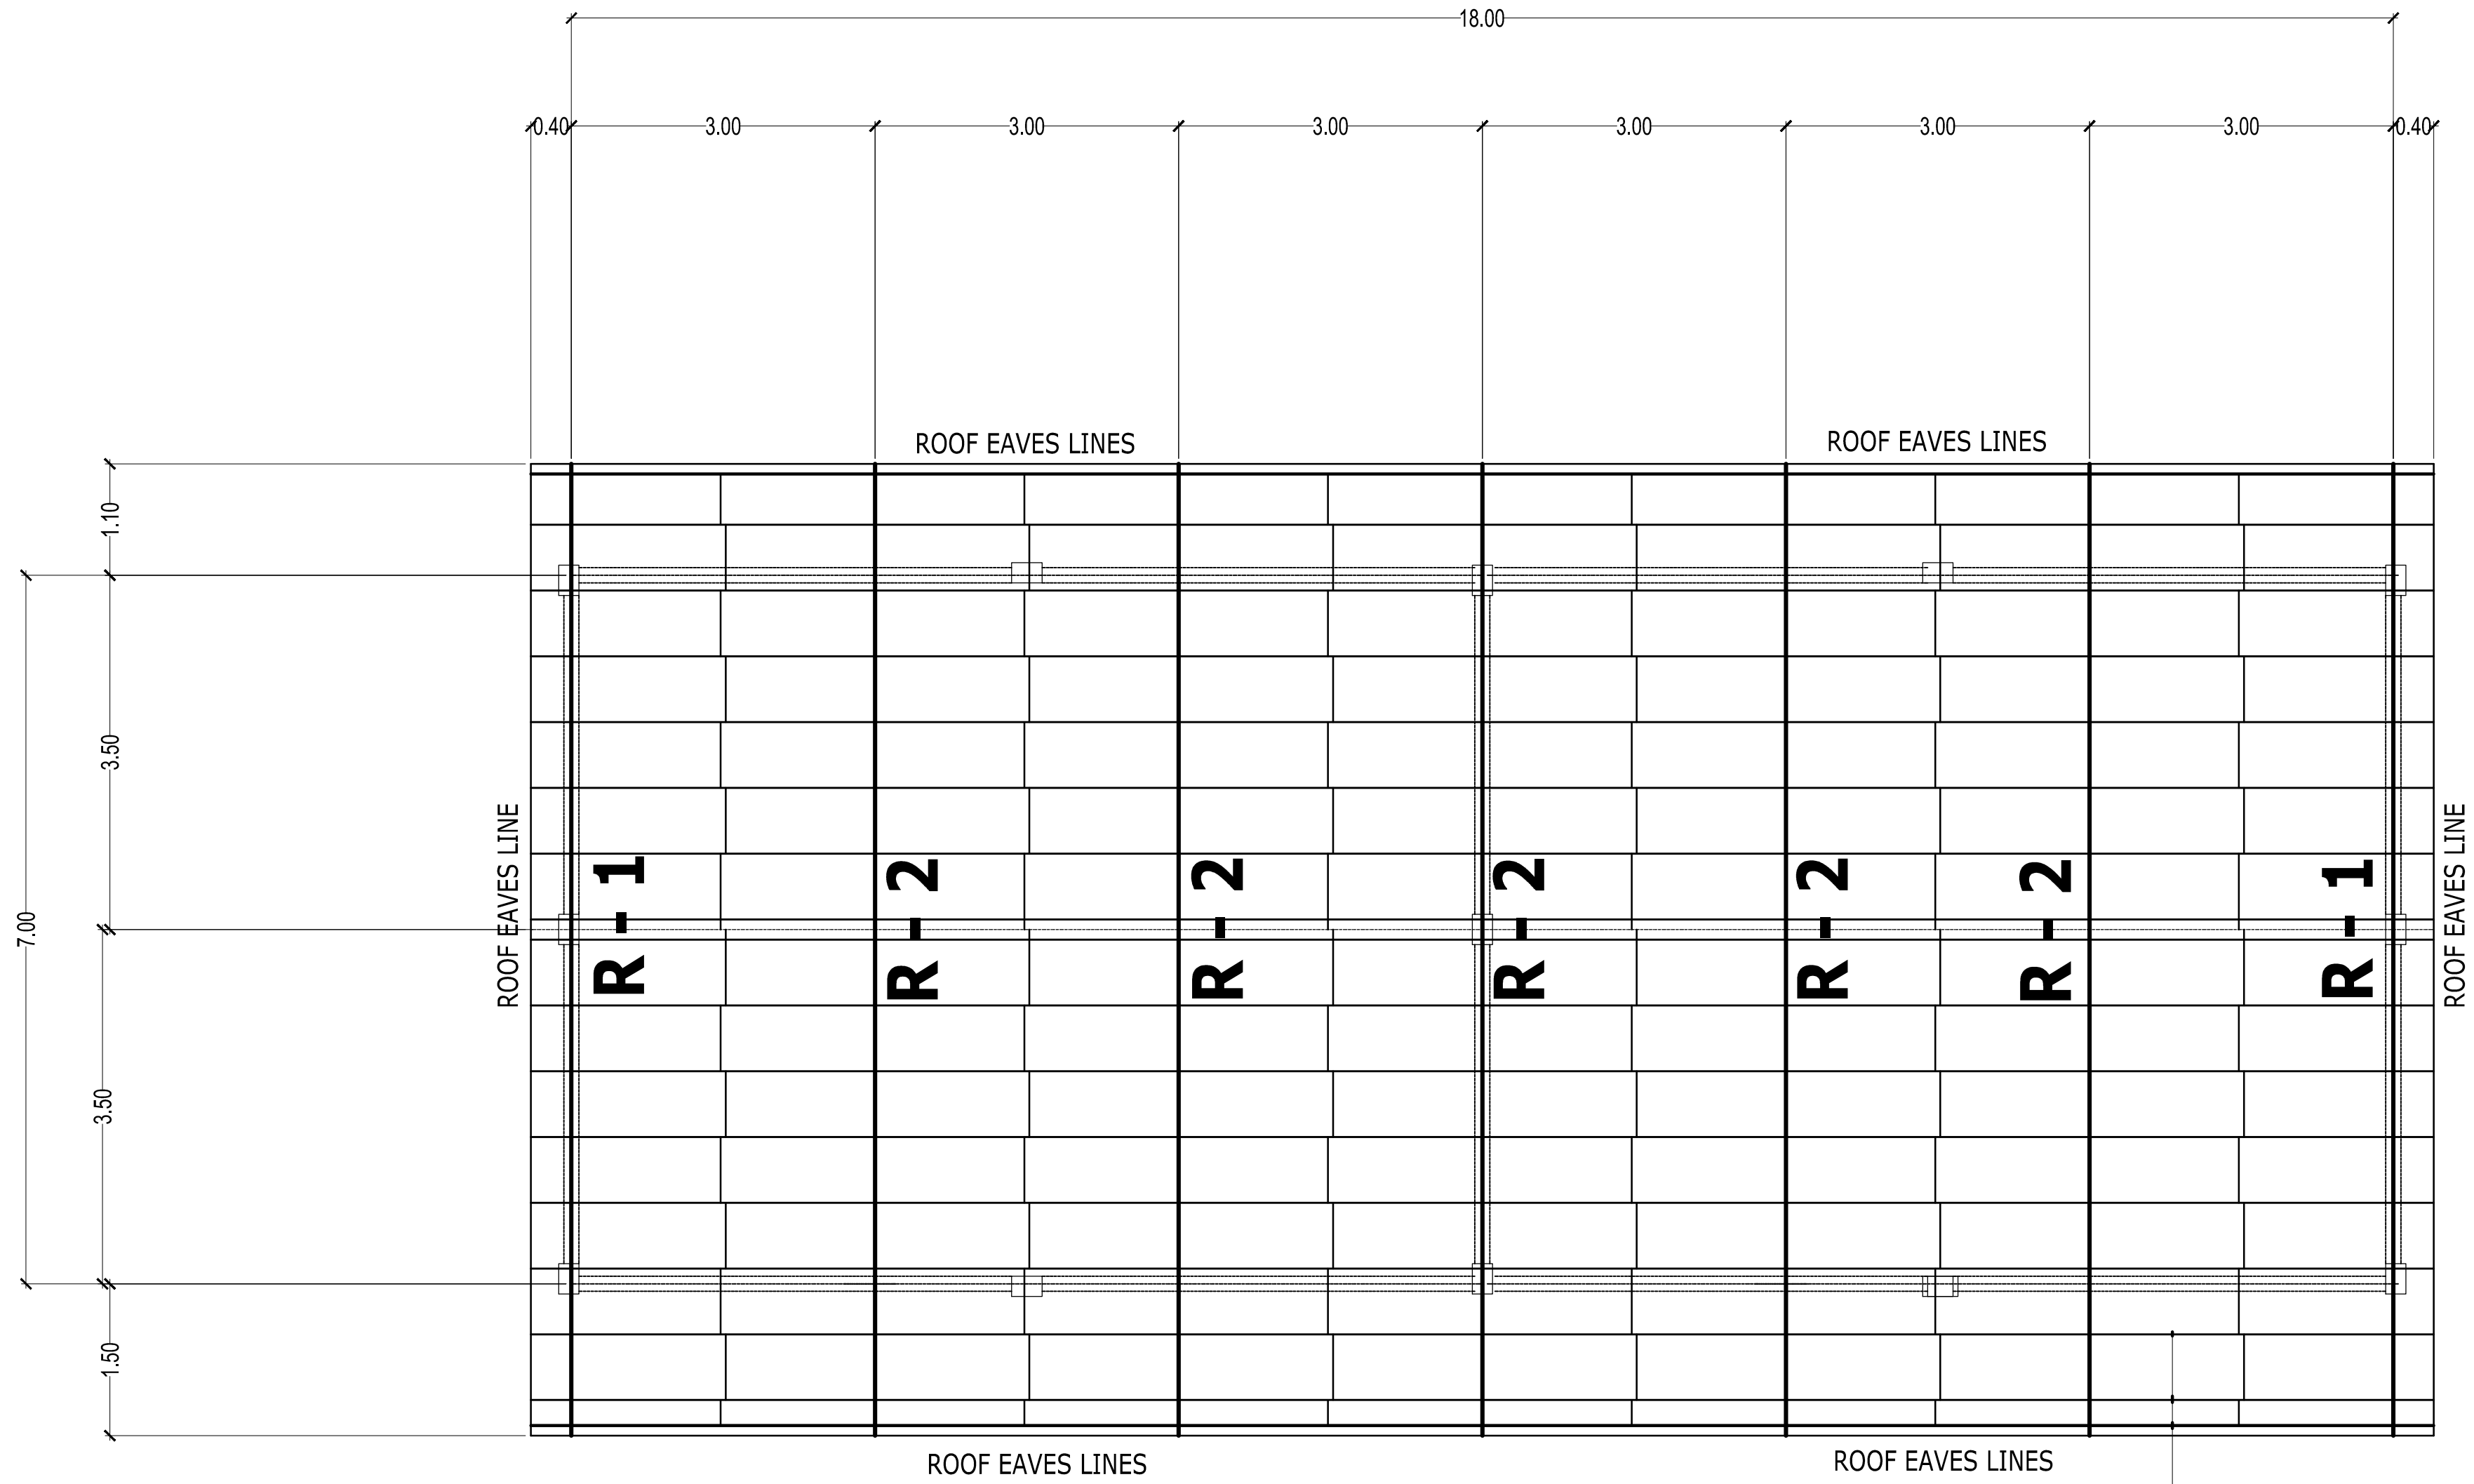


100x50x15x1.5mm
C-PURLINS SPACED
@ 0.70m. O.C.

ROOF FRAMING PLAN


SCALE

1 : 60 M.

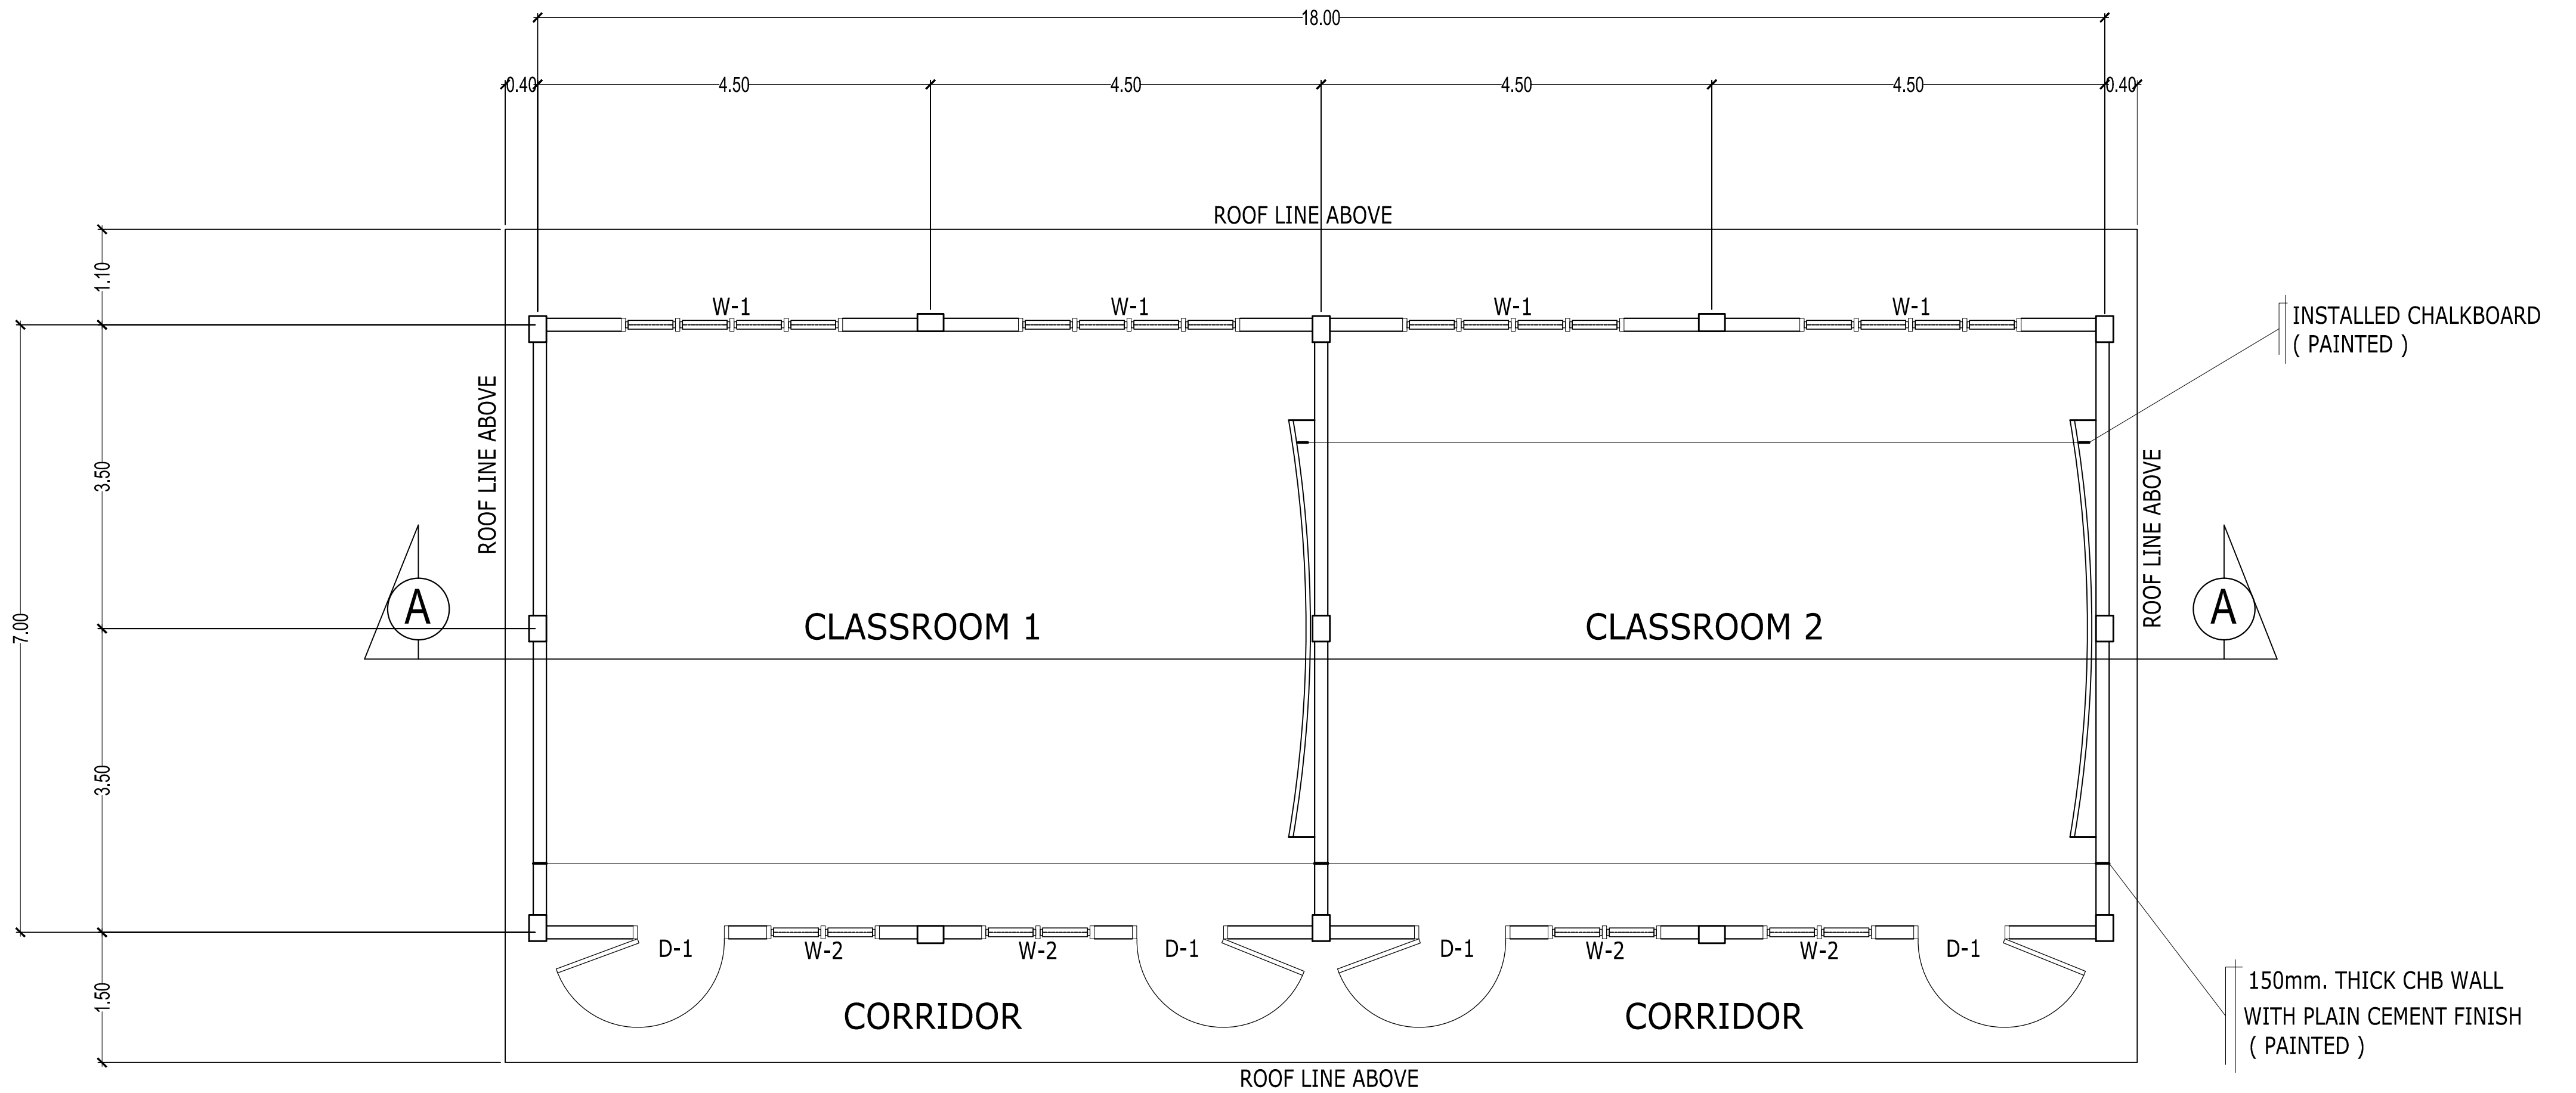

FLOOR PLAN

SCALE 1 : 100 M.

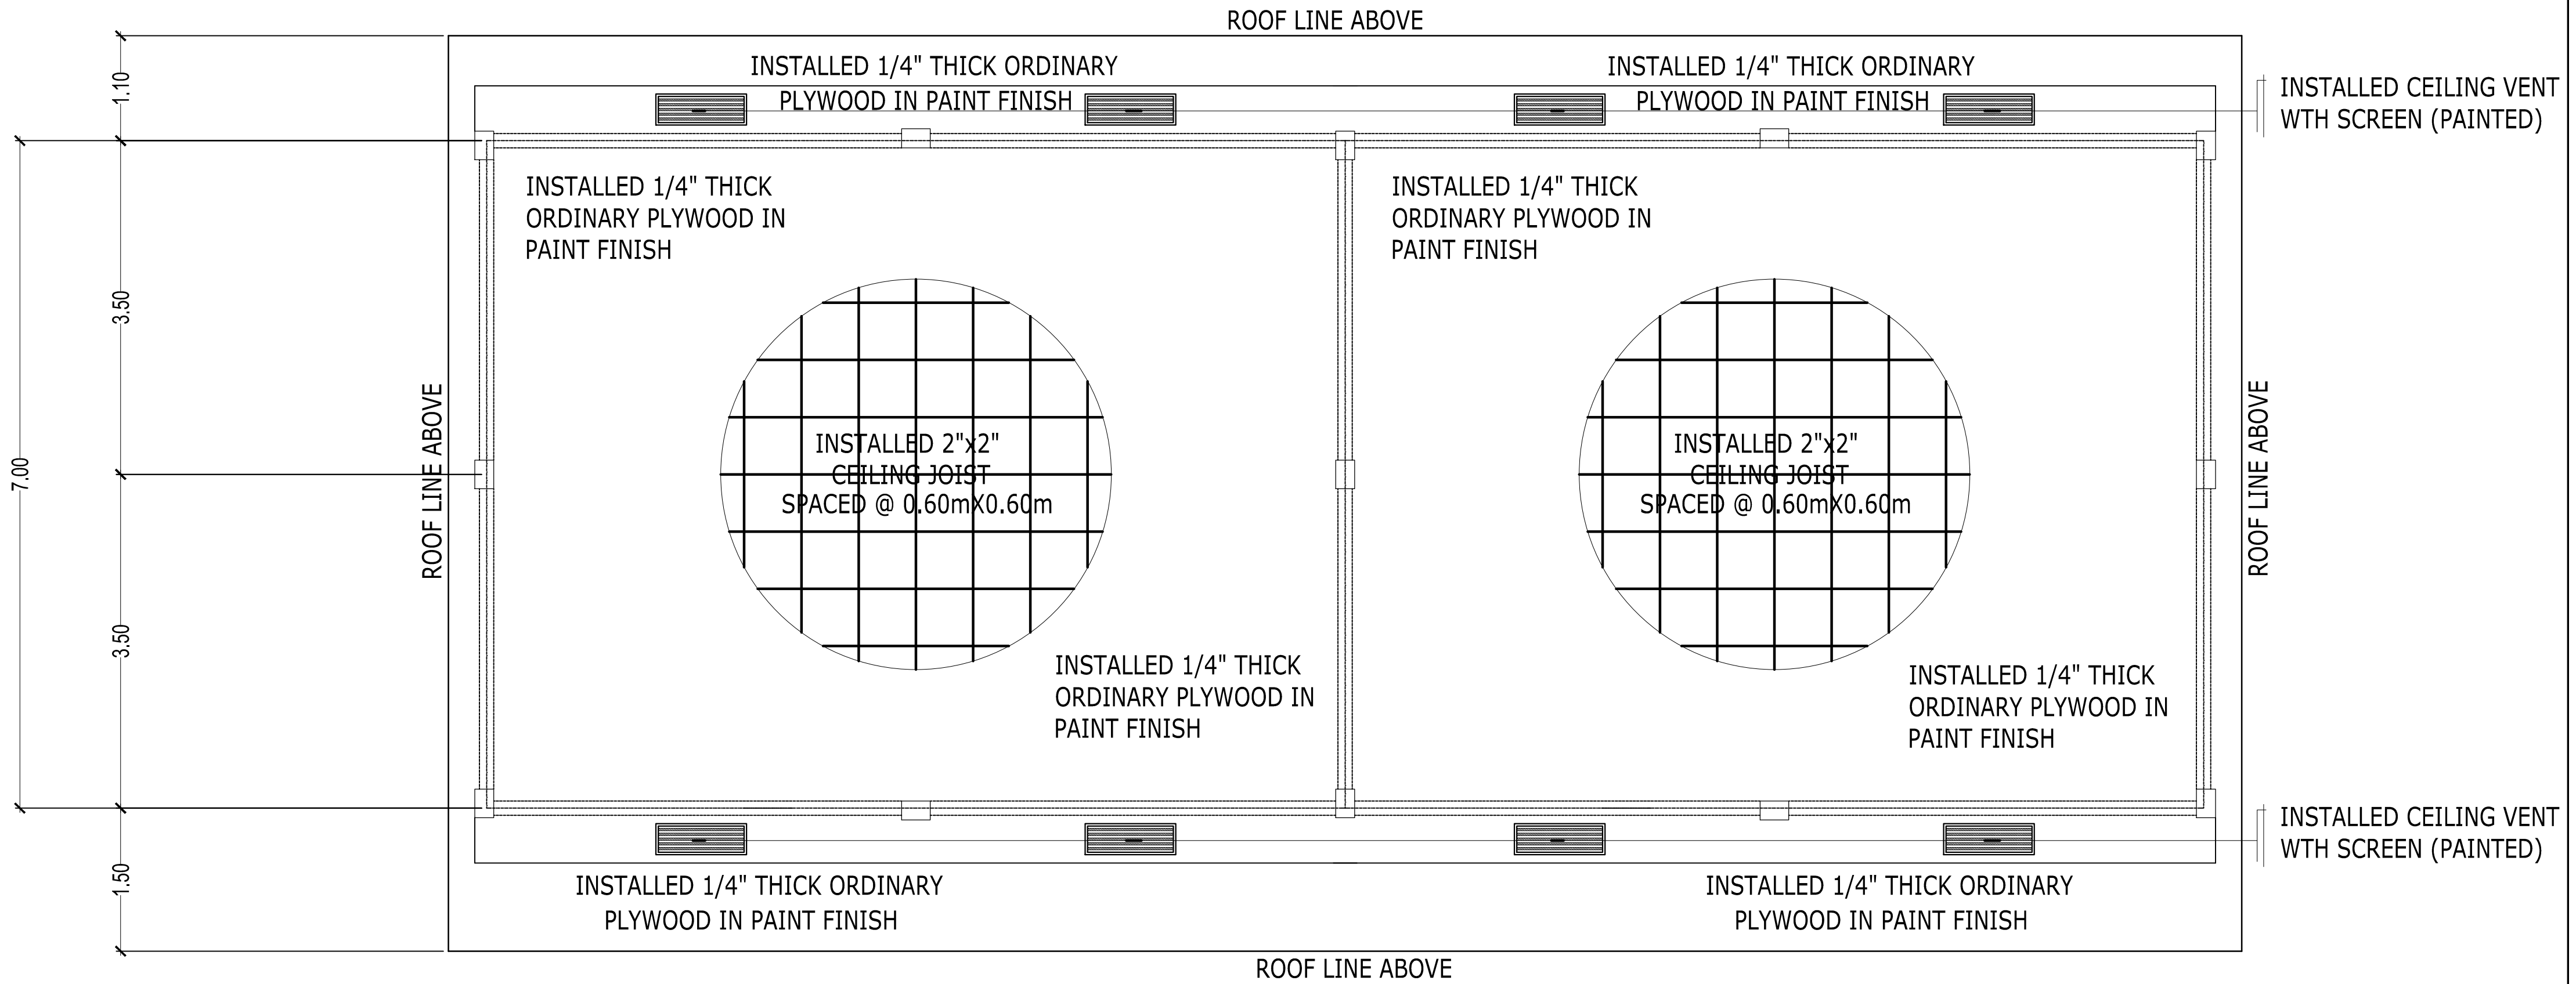

REFLECTED CEILING PLAN

SCALE

1 : 100 M.